

REVISIONS

DDC. NO. SPC-F005 * Effective: 7/8/02 * DCP No: 1398

DCP #	REV	DESCRIPTION	DRAWN	DATE	CHECKD	DATE	APPRVD	DATE
2075	A	RELEASED	JN	11/20/09	JN	11/20/09	JN	11/20/09



SPECIFICATIONS

Ratd Voltage: AC 300V

Rated current: 6A

Wire Size: 26~16 AWG

Housing Material: Polyamide66 (UL94V-0)

Terminal: Brass, Tin Plated


Wire Protector: Phosphor bronze, Tin Plated

Screw Size: M2.0, Steel, Zinc Plated


Operating Tepmerature: -40°C to +105°C

Torque: 2.5 lb-inch

PCB Hole Diameter: Ø1.2mm

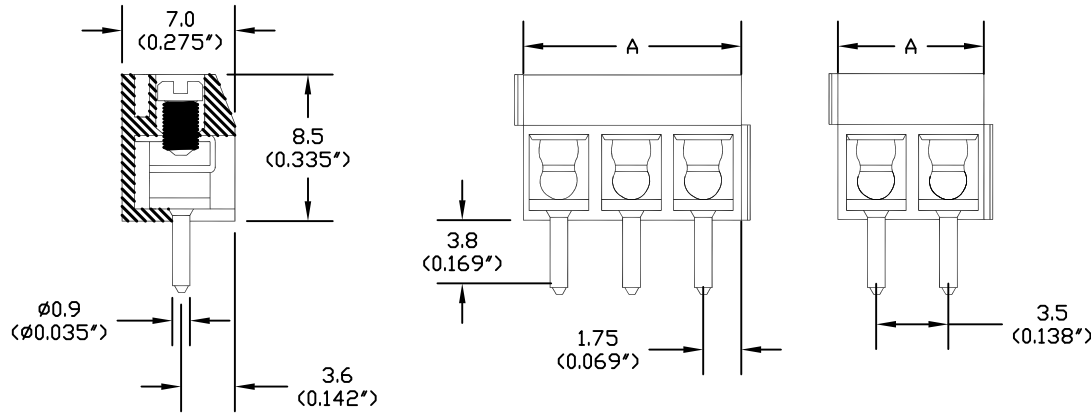

PCB Layout

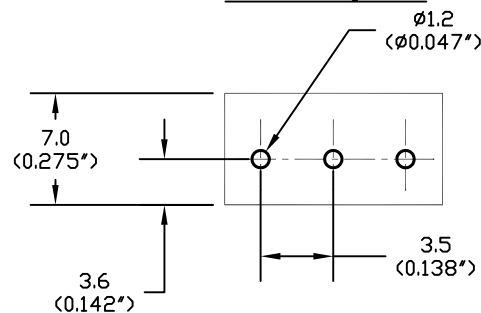

Pitch: 3.50mm (0.138inch)

Mfg. P/N	No. of Pins	(A) mm	(A) inches
MA212-350M02	2	7	0.276
MA212-350M03	3	10.5	0.413
MA212-350M04	4	14	0.552
MA212-350M05	5	17.5	0.689
MA212-350M06	6	21	0.826
MA212-350M07	7	24.5	0.965
MA212-350M08	8	28	1.102
MA212-350M09	9	31.5	1.239
MA212-350M10	10	35	1.378
MA212-350M14	14	49	1.928
MA212-350M15	15	52.5	2.065
MA212-350M16	16	56	2.204

DISCLAIMER:
ALL STATEMENTS AND TECHNICAL INFORMATION CONTAINED HEREIN ARE BASED UPON INFORMATION AND/OR TESTS WE BELIEVE TO BE ACCURATE AND RELIABLE. SINCE CONDITIONS OF USE ARE BEYOND OUR CONTROL, THE USER SHALL DETERMINE THE SUITABILITY OF THE PRODUCT FOR THE INTENDED USE AND ASSUME ALL RISK AND LIABILITY WHATSOEVER IN CONNECTION THEREWITH.

TOLERANCES:

UNLESS OTHERWISE SPECIFIED, DIMENSIONS ARE FOR REFERENCE PURPOSES ONLY.

DRAWN BY:

Jason Nash

CHECKED BY:

Jason Nash

APPROVED BY:

Jason Nash

DATE:

11/20/09

DATE:

11/20/09

DATE:

11/20/09

DRAWING TITLE:

Terminal Block

SIZE DWG. NO.

A

Ta-1207

ELECTRONIC FILE

Ta-1207.dwg

REV

A

SCALE: NTS

U.O.M.: INCHES [mm]

SHEET: 1 OF 1